

2

06/19/08

**Professional and Consulting
Electrical Engineering**
garjoe@epsfresno.com
joe@epsfresno.com
4049 N. FRESNO ST., FRESNO, CA 93726
Phone: (559) 221-7230 FAX: 221-0507
Job#: EC-08-03301 Date: MAY 2008

[illegible]

STAMP:



PROJECT:
COMPUTER SERVICES CENTER ELECT. UPGRADE
CLOVIS, CALIFORNIA

SHEET CONTENT:

DRAWN BY:	CRT	CHECKED BY:	VM
ISSUE DATE:	CONCEPT ONLY	CONTRACT NO:	X
ARCHIVE NAME:			

ES-2


UPDATED: 06/19/08




A1	ELECTRICAL SITE PLAN 3/16" = 1'-0"
----	---------------------------------------


A10	SECTION C-C ELEVATION 3/8" = 1'-0"
-----	---------------------------------------

G10 SECTION A-A ELEVATION
3/8" = 1'-0"

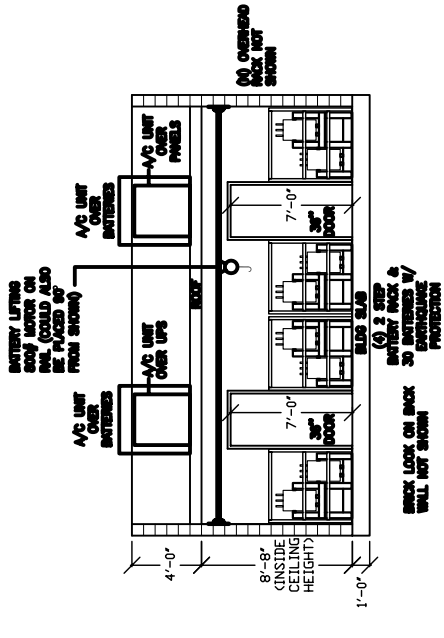

D10 SECTION B-B ELEVATION

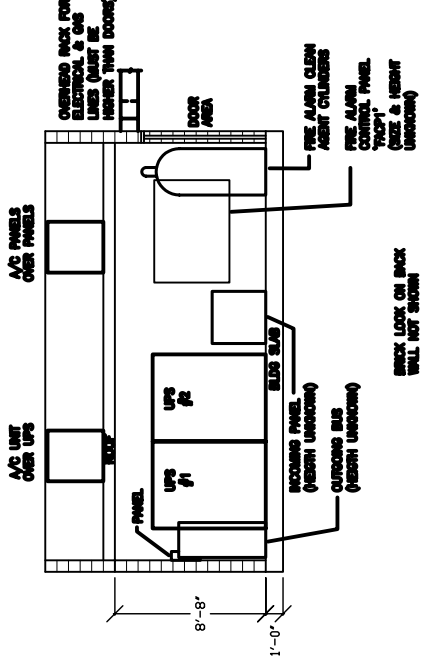

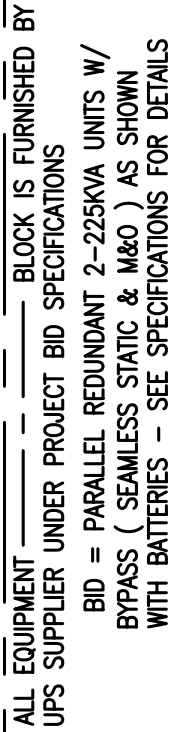

EXISTING BATTERY BANK MODIFIED WITH BID – ADD BATTERIES AS SPECIFIED	NEW BATTERY BANK FURNISHED WITH BID
--	--

ELECTRICAL P. S. INC.
POWER SYSTEMS
Professional and Consulting
Electrical Engineering
Since 1974

GARY R. OLSEN, P.E.
CA. EE 8283
JOE PREVENDAR, P.E.
CA. EE 16581
4049 N. FRESNO ST
FRESNO, CA 93726
(559) 221-7230
FAX: 221-0507
gary@epsfresno.com
joe@epsfresno.com

FC3301- CSC UPS ELECTRIC UPGRADE

FC/33.01/DWGS/BID SYSTEM 8-19-08

DATE: 05/2008
JOB#: FC3301

SCALE: 1 = 1
REF. #: EPS11x8

FC3301-BID-1of1