
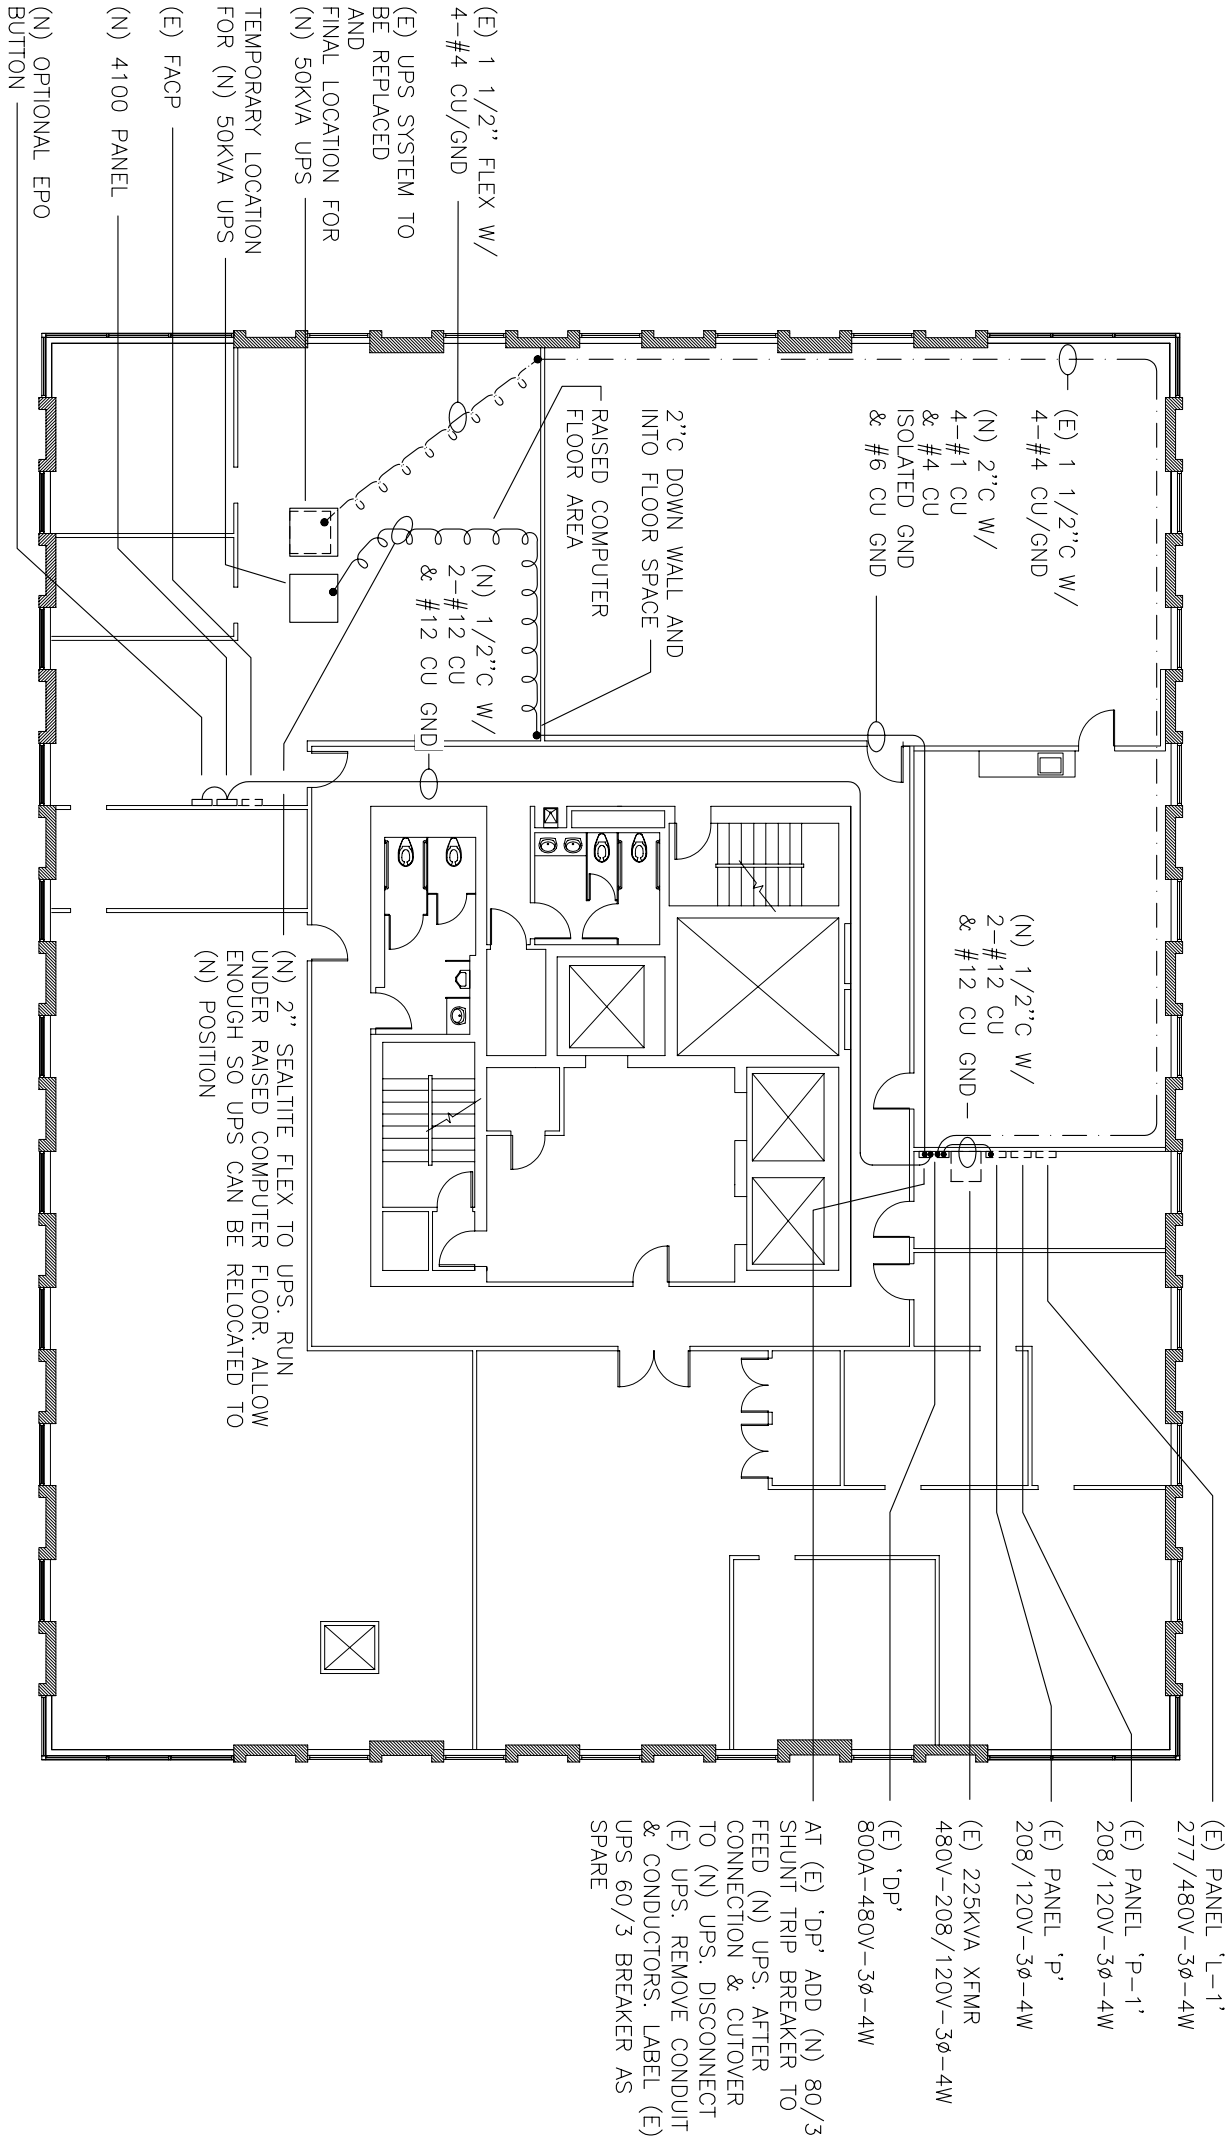


21ST FLOOR ELECTRICAL PLAN

NOT TO SCALE

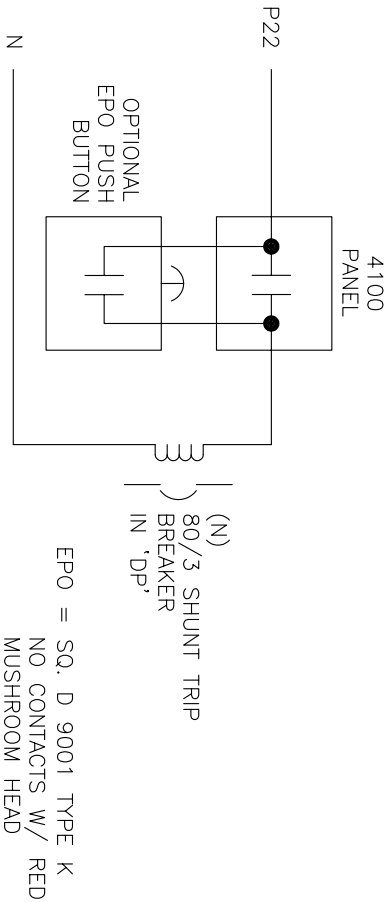

DATE: OCTOBER 6, 2008
JOB #: FC-08-033.05
DESIGNED BY: VM
DRAWN BY: CRT
SCALE: AS SHOWN
DWG #: FC33.5E2-FP

REVISIONS			
NO.	DATE	REVISION	



GARY R. OLSEN, PE CA. EE 8283
JOE PREVENDAR, PE CA. EE 16581
4049 NORTH FRESNO ST.
FRESNO, CA 93726
559-221-7230 FAX 559-221-0507
gary@epsfresno.com
joe@epsfresno.com

ELECTRICAL PLAN
PLAZA TOWER 21ST FLOOR
FRESNO, CA